



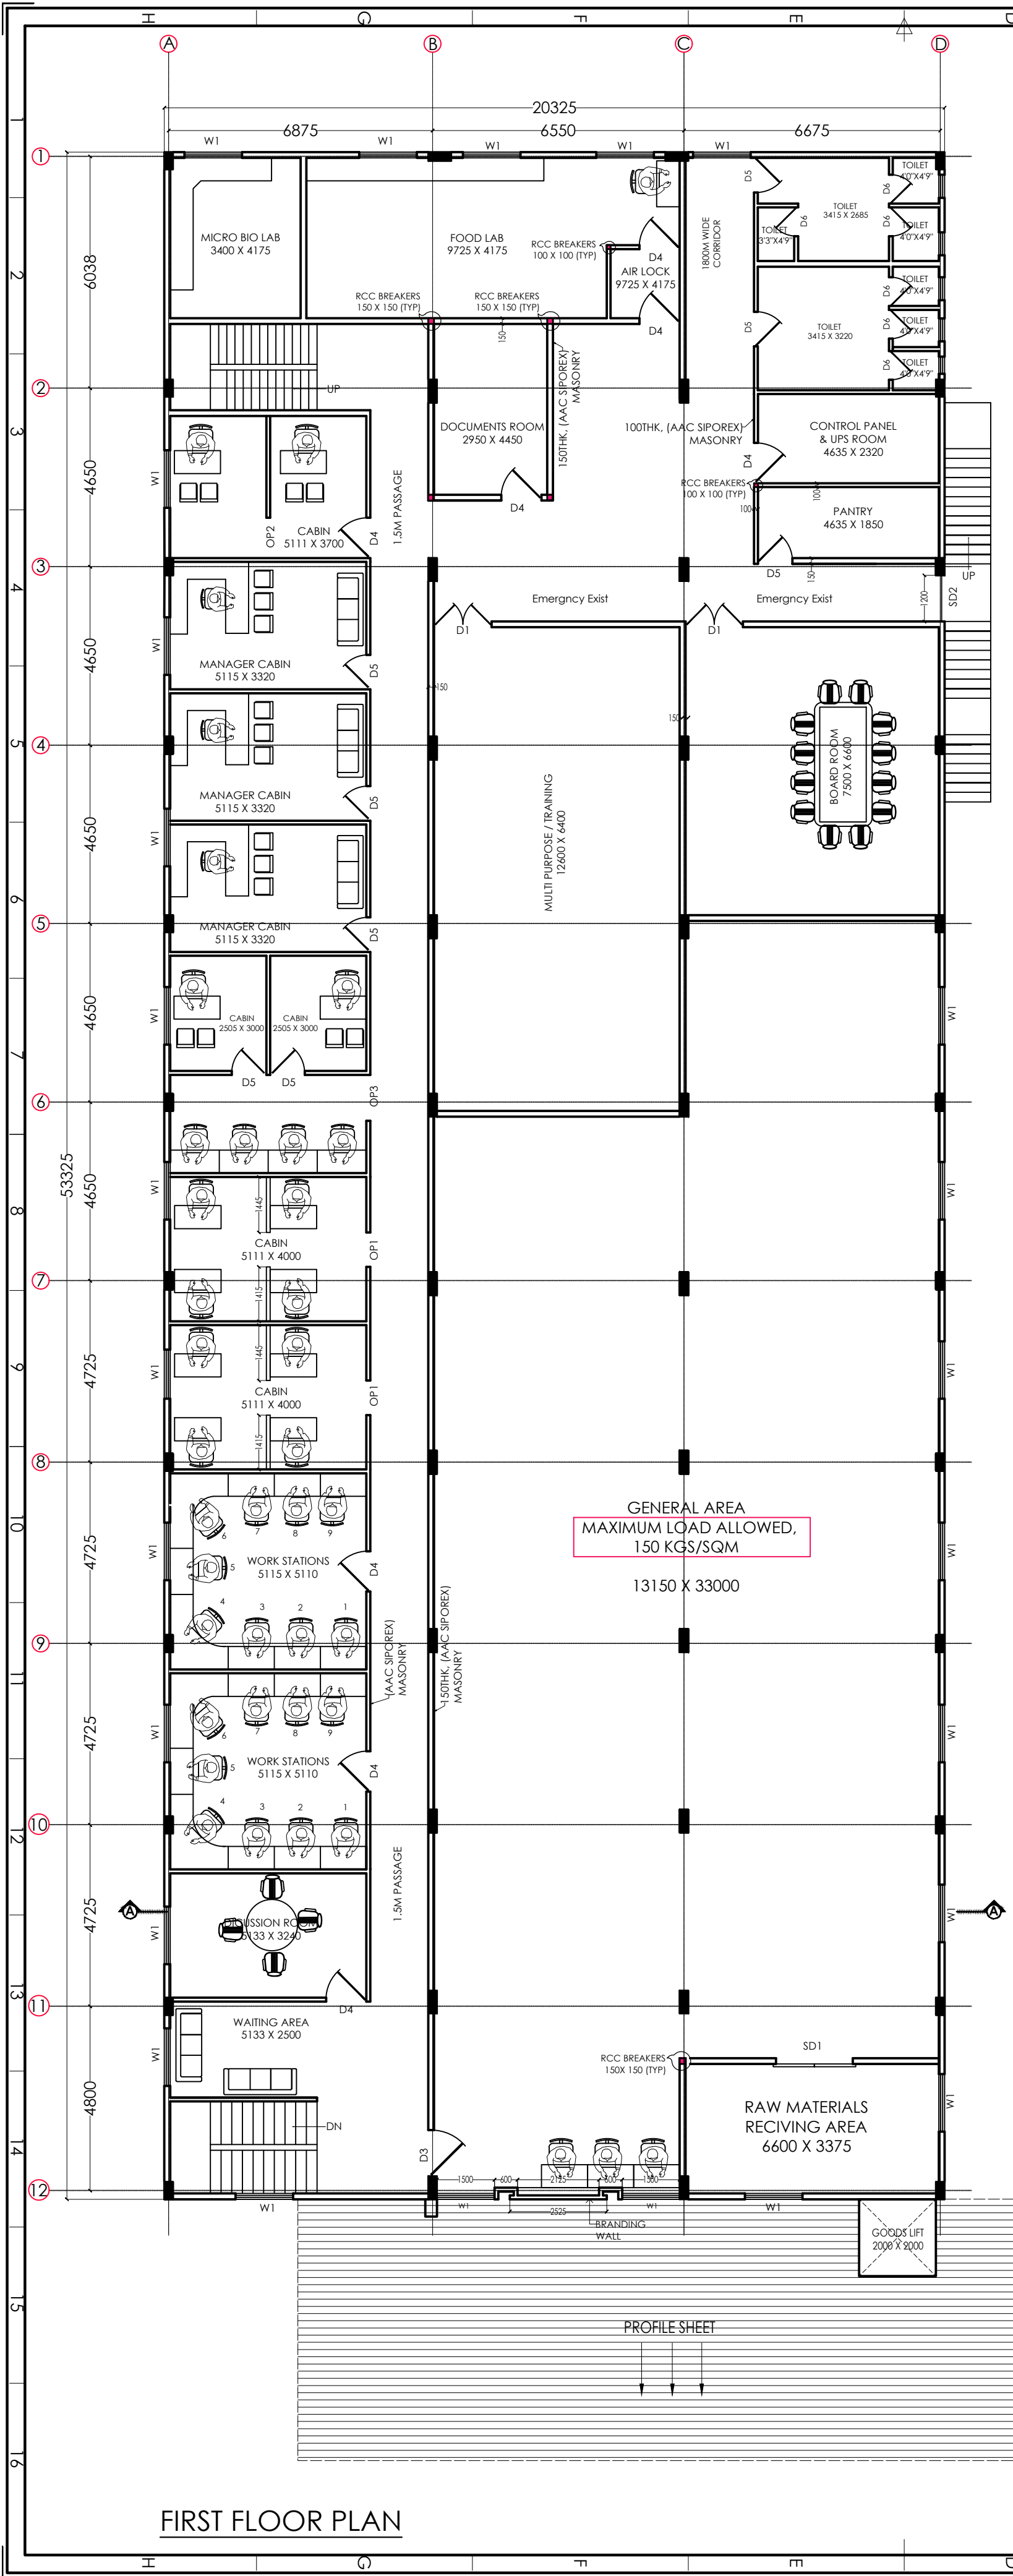


FIRST FLOOR PLAN

RCC BREAKERS DETAILS		
	SECTION	REINFORCEMENT
RCC BREAKERS 6" X 6"		● 4-Y10 STPS : Y8 @ 200C/C
RCC BREAKERS 4" X 4"		● 4-Y10 STPS : Y8 @ 200C/C

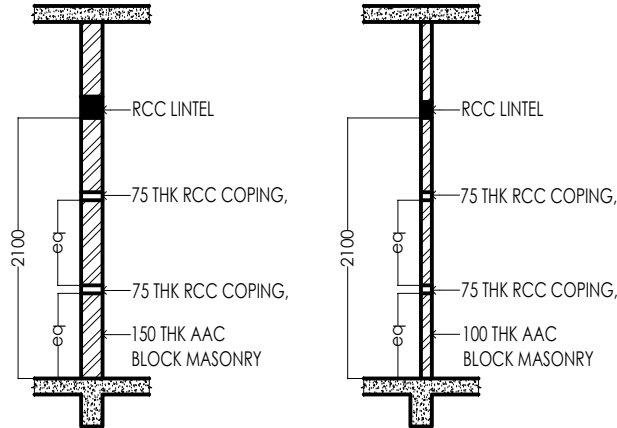

TYP 200 WALL SECTION TYP 100 WALL SECTION

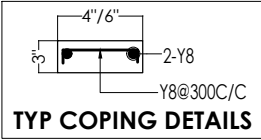

TYP COPING DETAILS

SCHEDULE OF OPENINGS:

DOOR :

MD	: 1800 X 2450
D0	: 1650 X 2450
D1	: 1500 X 2450
D2	: 1350 X 2450
D3	: 1200 X 2450
D4	: 1050 X 2450
D5	: 900 X 2450
D6	: 750 X 2150

WINDOW :

INDEX	SIZE	SILL LVL	TOP LVL
W1	: 1500 X 1500	+950	+2450
W2	: 1200 X 1500	+950	+2450

ROOLING SHUTTER :

INDEX	SIZE	SILL LVL	TOP LVL
RS1	: 3500 X 3000	+0	@BEAM BOT
RS2	: 1500 X 3000	+0	@BEAM BOT
RS3	: 1200 X 1550	+900	+2450

CONVEYOR CUTOUT:

INDEX	SIZE	SILL LVL	TOP LVL
MSD1:	900 X 1200	+0	+1200

DOOR OPEINGS :

OP1	: 900 X 2450
OP2	: 1050 X 2450
OP3	: 1200 X 2450

SLIDDING DOOR :

SD1	: 2500 X 2450
SD2	: 1200 X 2450

R3	06.05.2023	GENERAL REVISION
R2	07.03.2023	GENERAL REVISION
R1	17.10.2024	GENERAL REVISION
NO.	DATE	DESCRIPTION
REVISIONS:		
PROJECT:		
PROPOSED KITCHEN FACILITY FOR THE AKSHAY PATRA FOUNDATION AT SITE NO.72/19-6, SITUATED AT RAJAJINAGAR INDUSTRIAL SUBURB, BANGALORE.		
CLIENT:		
		
ARCHITECTS:		
 HEGDE AND HEGDE ARCHITECTURE * ENGINEERING * INTERIORS B11 MARVEL, 50/81, 1st FLOOR, PANDURANG ROAD, CHANDRANAGAR, BANGALORE - 560011 PH: 0836 2374312, email: hanch@hegdeandhegde.com R3 FIRST FLOOR WITH CROSS & PHASE GRADING, BANGALORE - 560011 PH: 0836 2374312, email: hanch@hegdeandhegde.com		
STRUCTURAL CONSULTANTS:		
NAGESH CONSULTANTS #2, BALAJI HOUSING SOCIETY, 8TH CROSS, ASHOKNAGAR 8TH STAGE, BANGALORE - 560035.		
MEP CONSULTANTS:		
Poorna Engineering Consultants #48/3, 8th A, MAIN, 1STAGE, 8 PHASE, CHANDRANAGAR, BANGALORE.		
TITLE:		NORTH
FF PLAN		
DWG NO:	GFC-A-02	R3
DRAWN BY:	TSB	FTS
DATE:	07.10.2024	

GOOD FOR CONSTRUCTION